





AIR WASHER

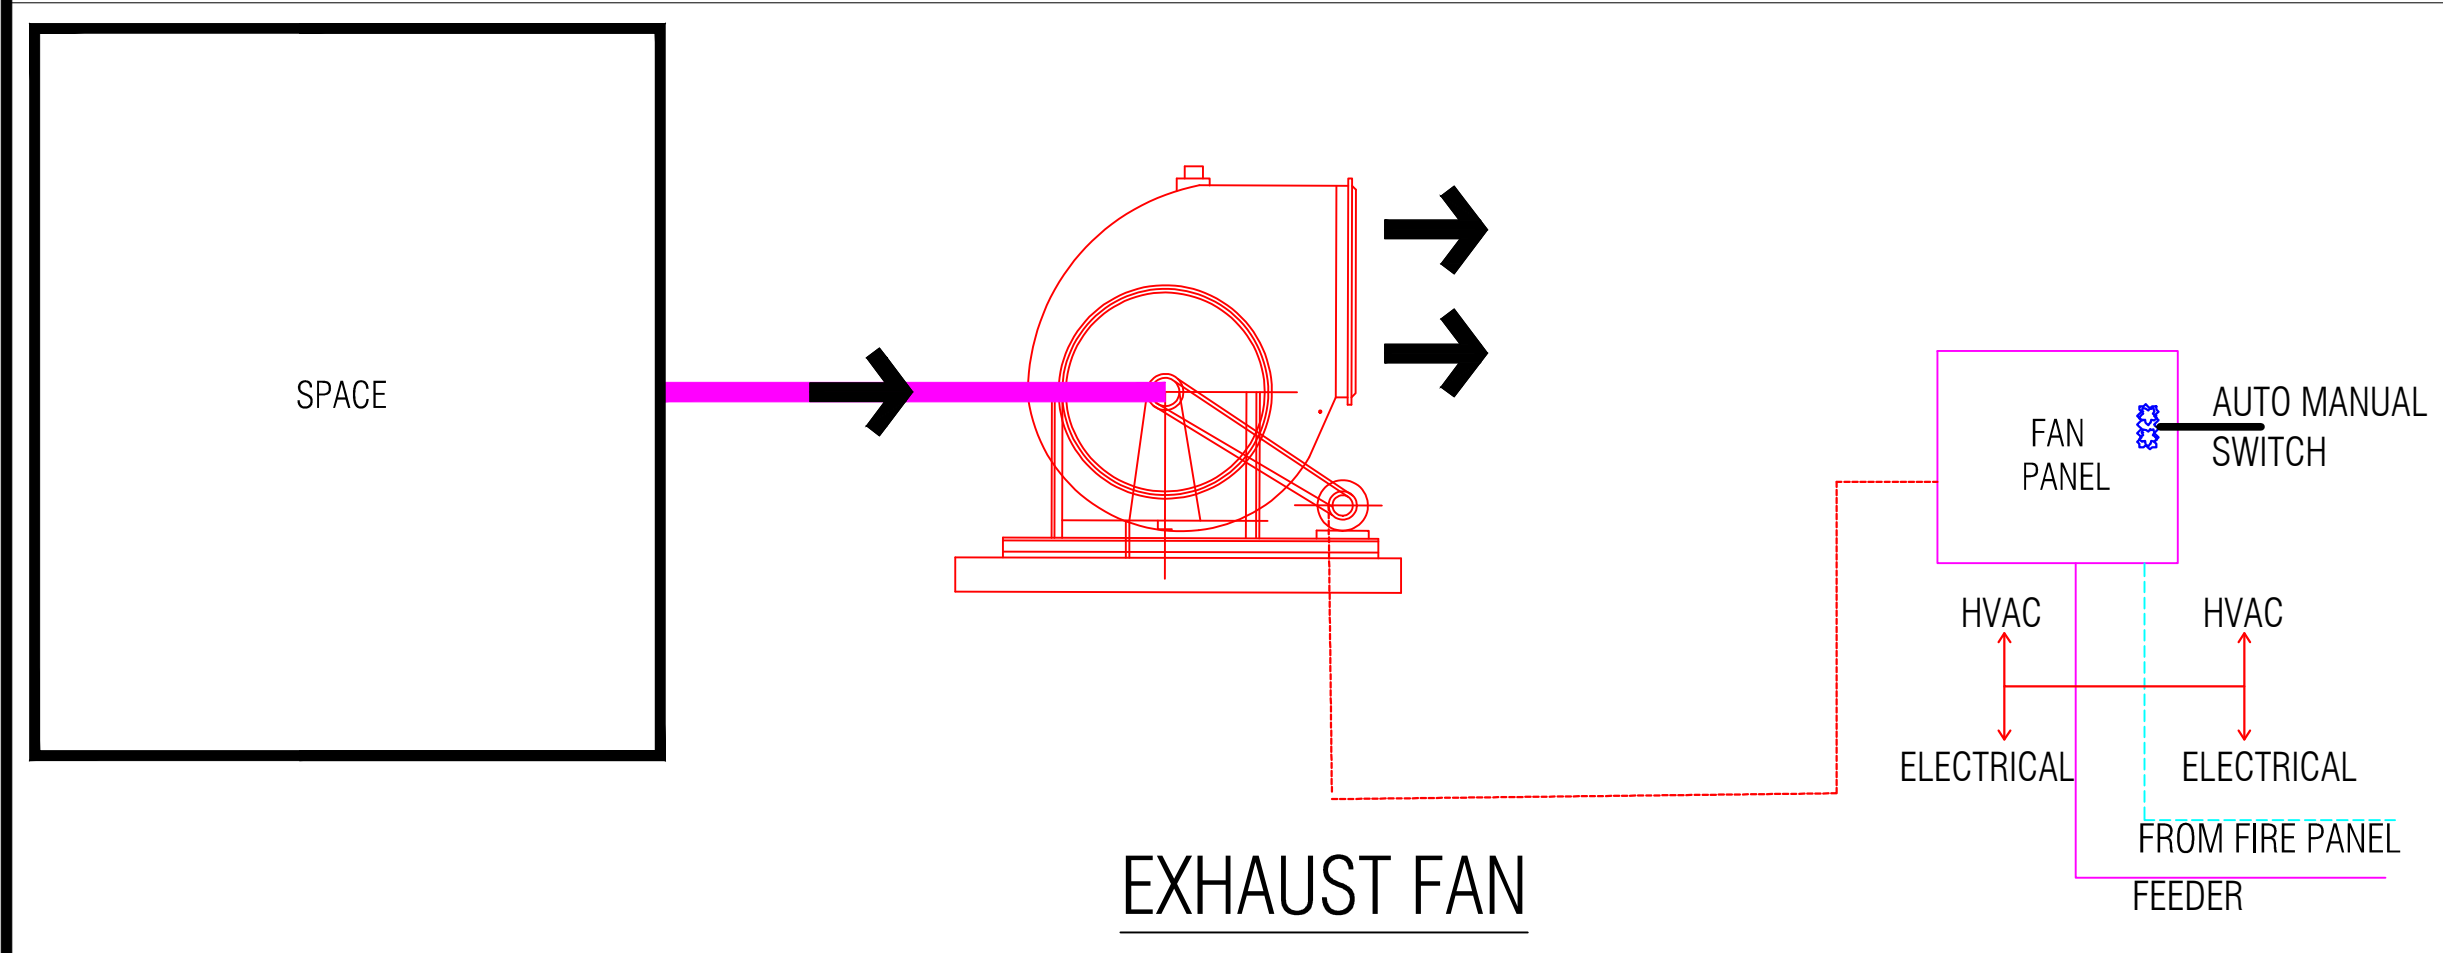

EXHAUST FAN

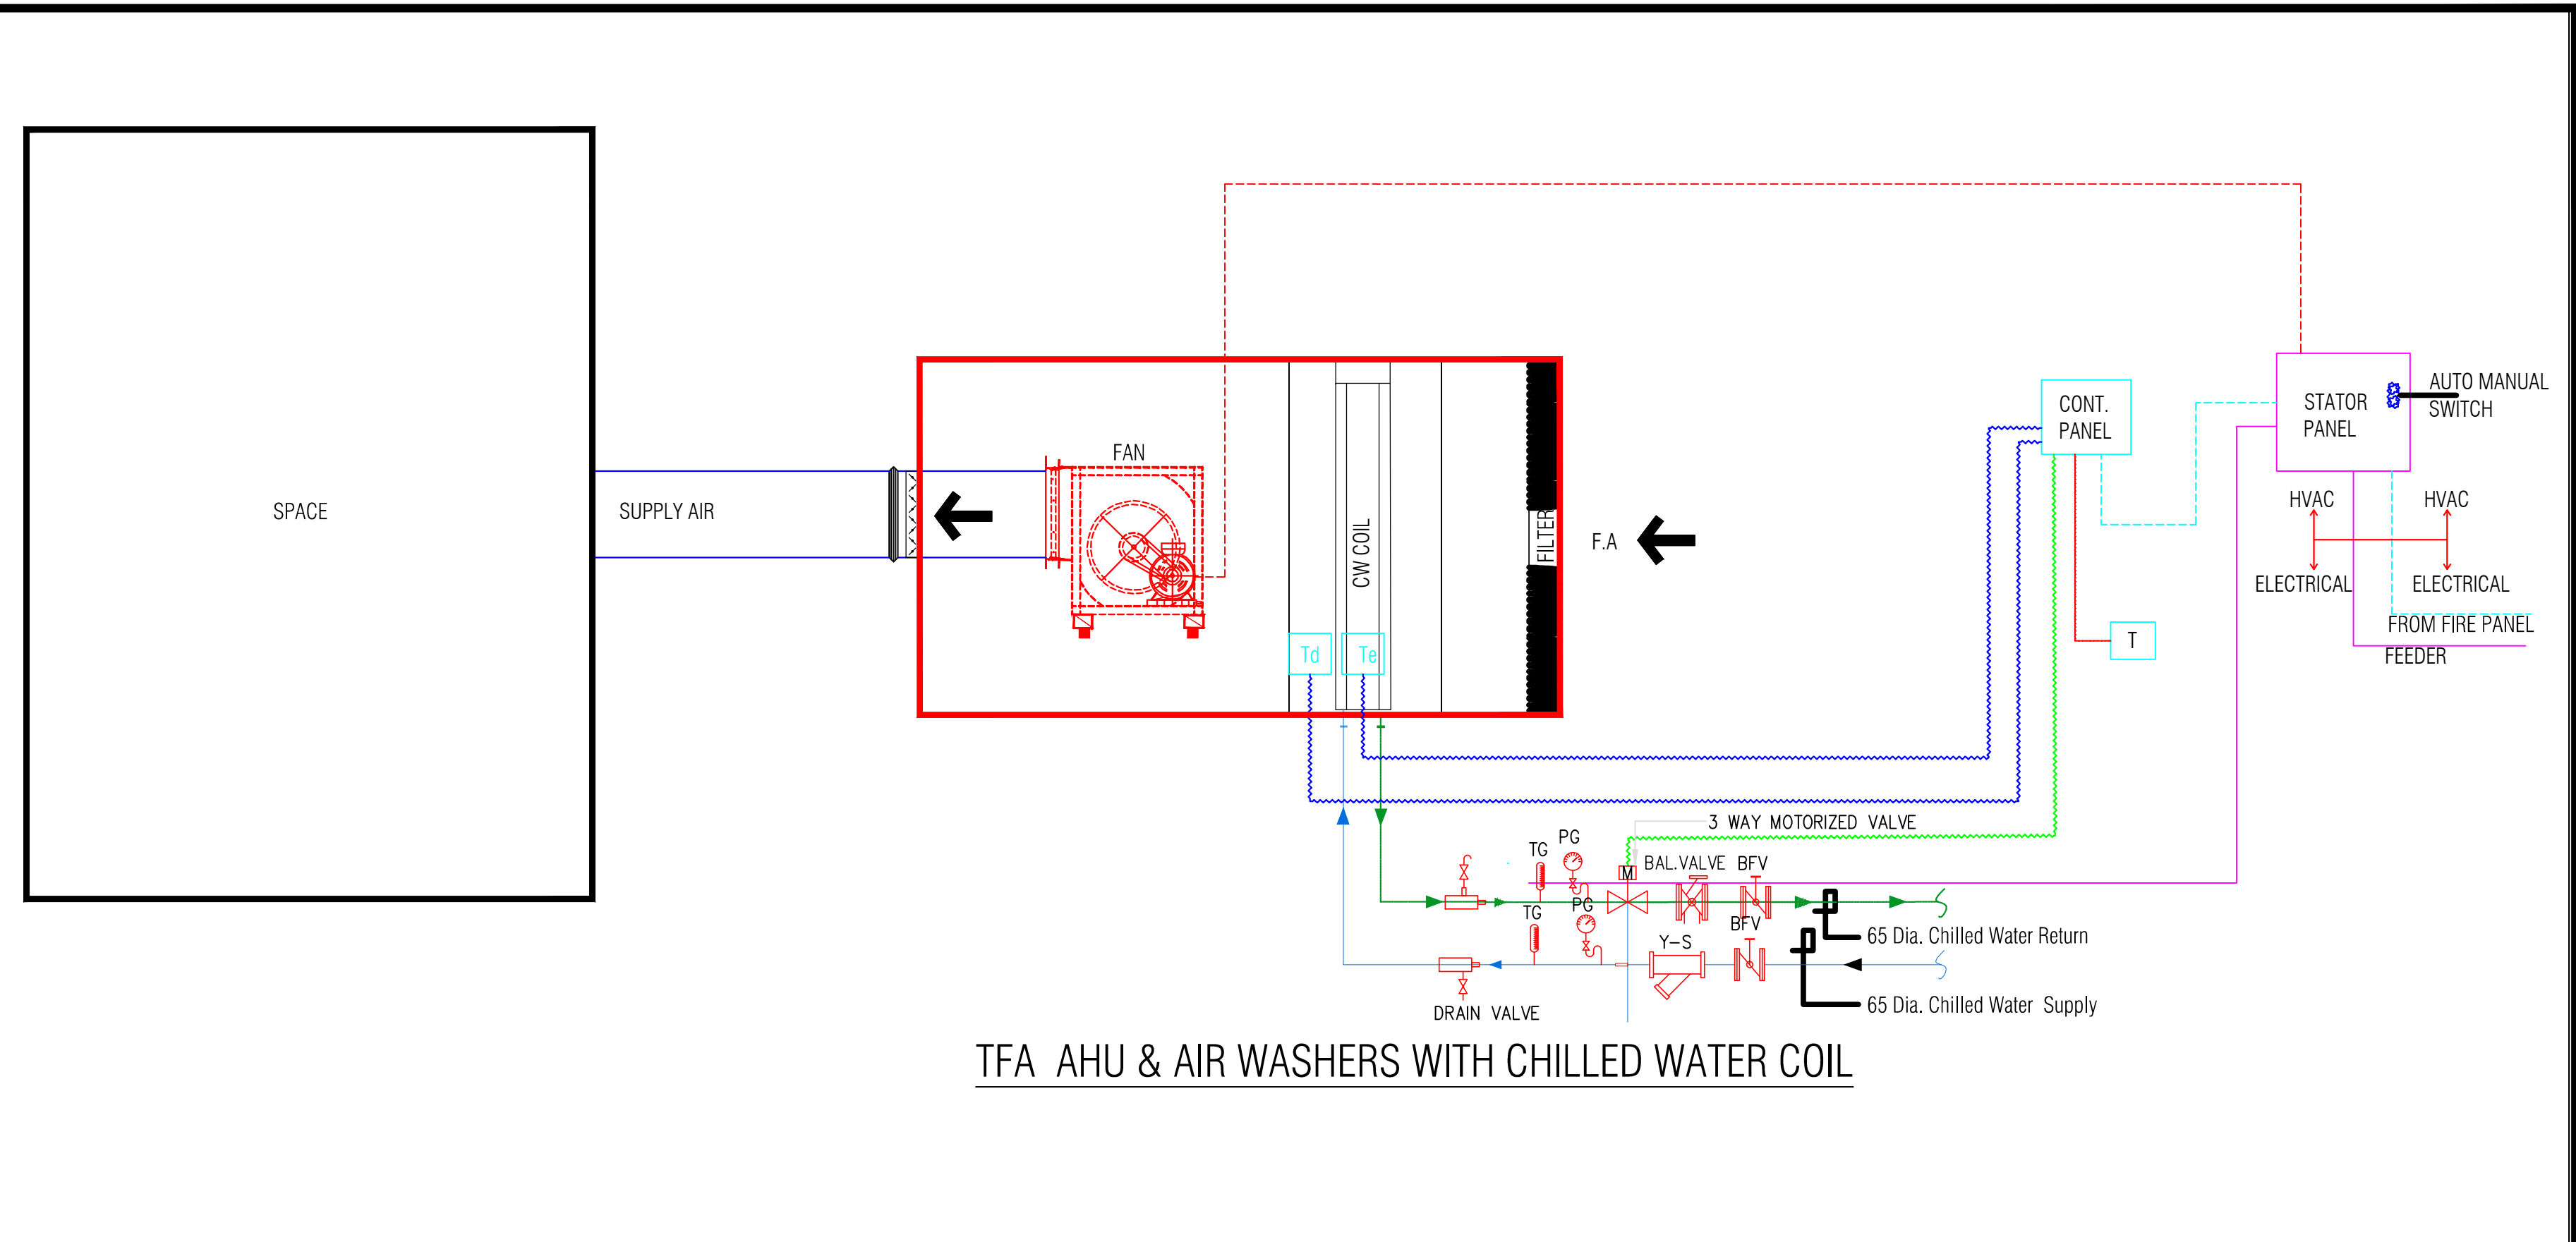

TFA AHU & AIR WASHERS WITH CHILLED WATER COIL

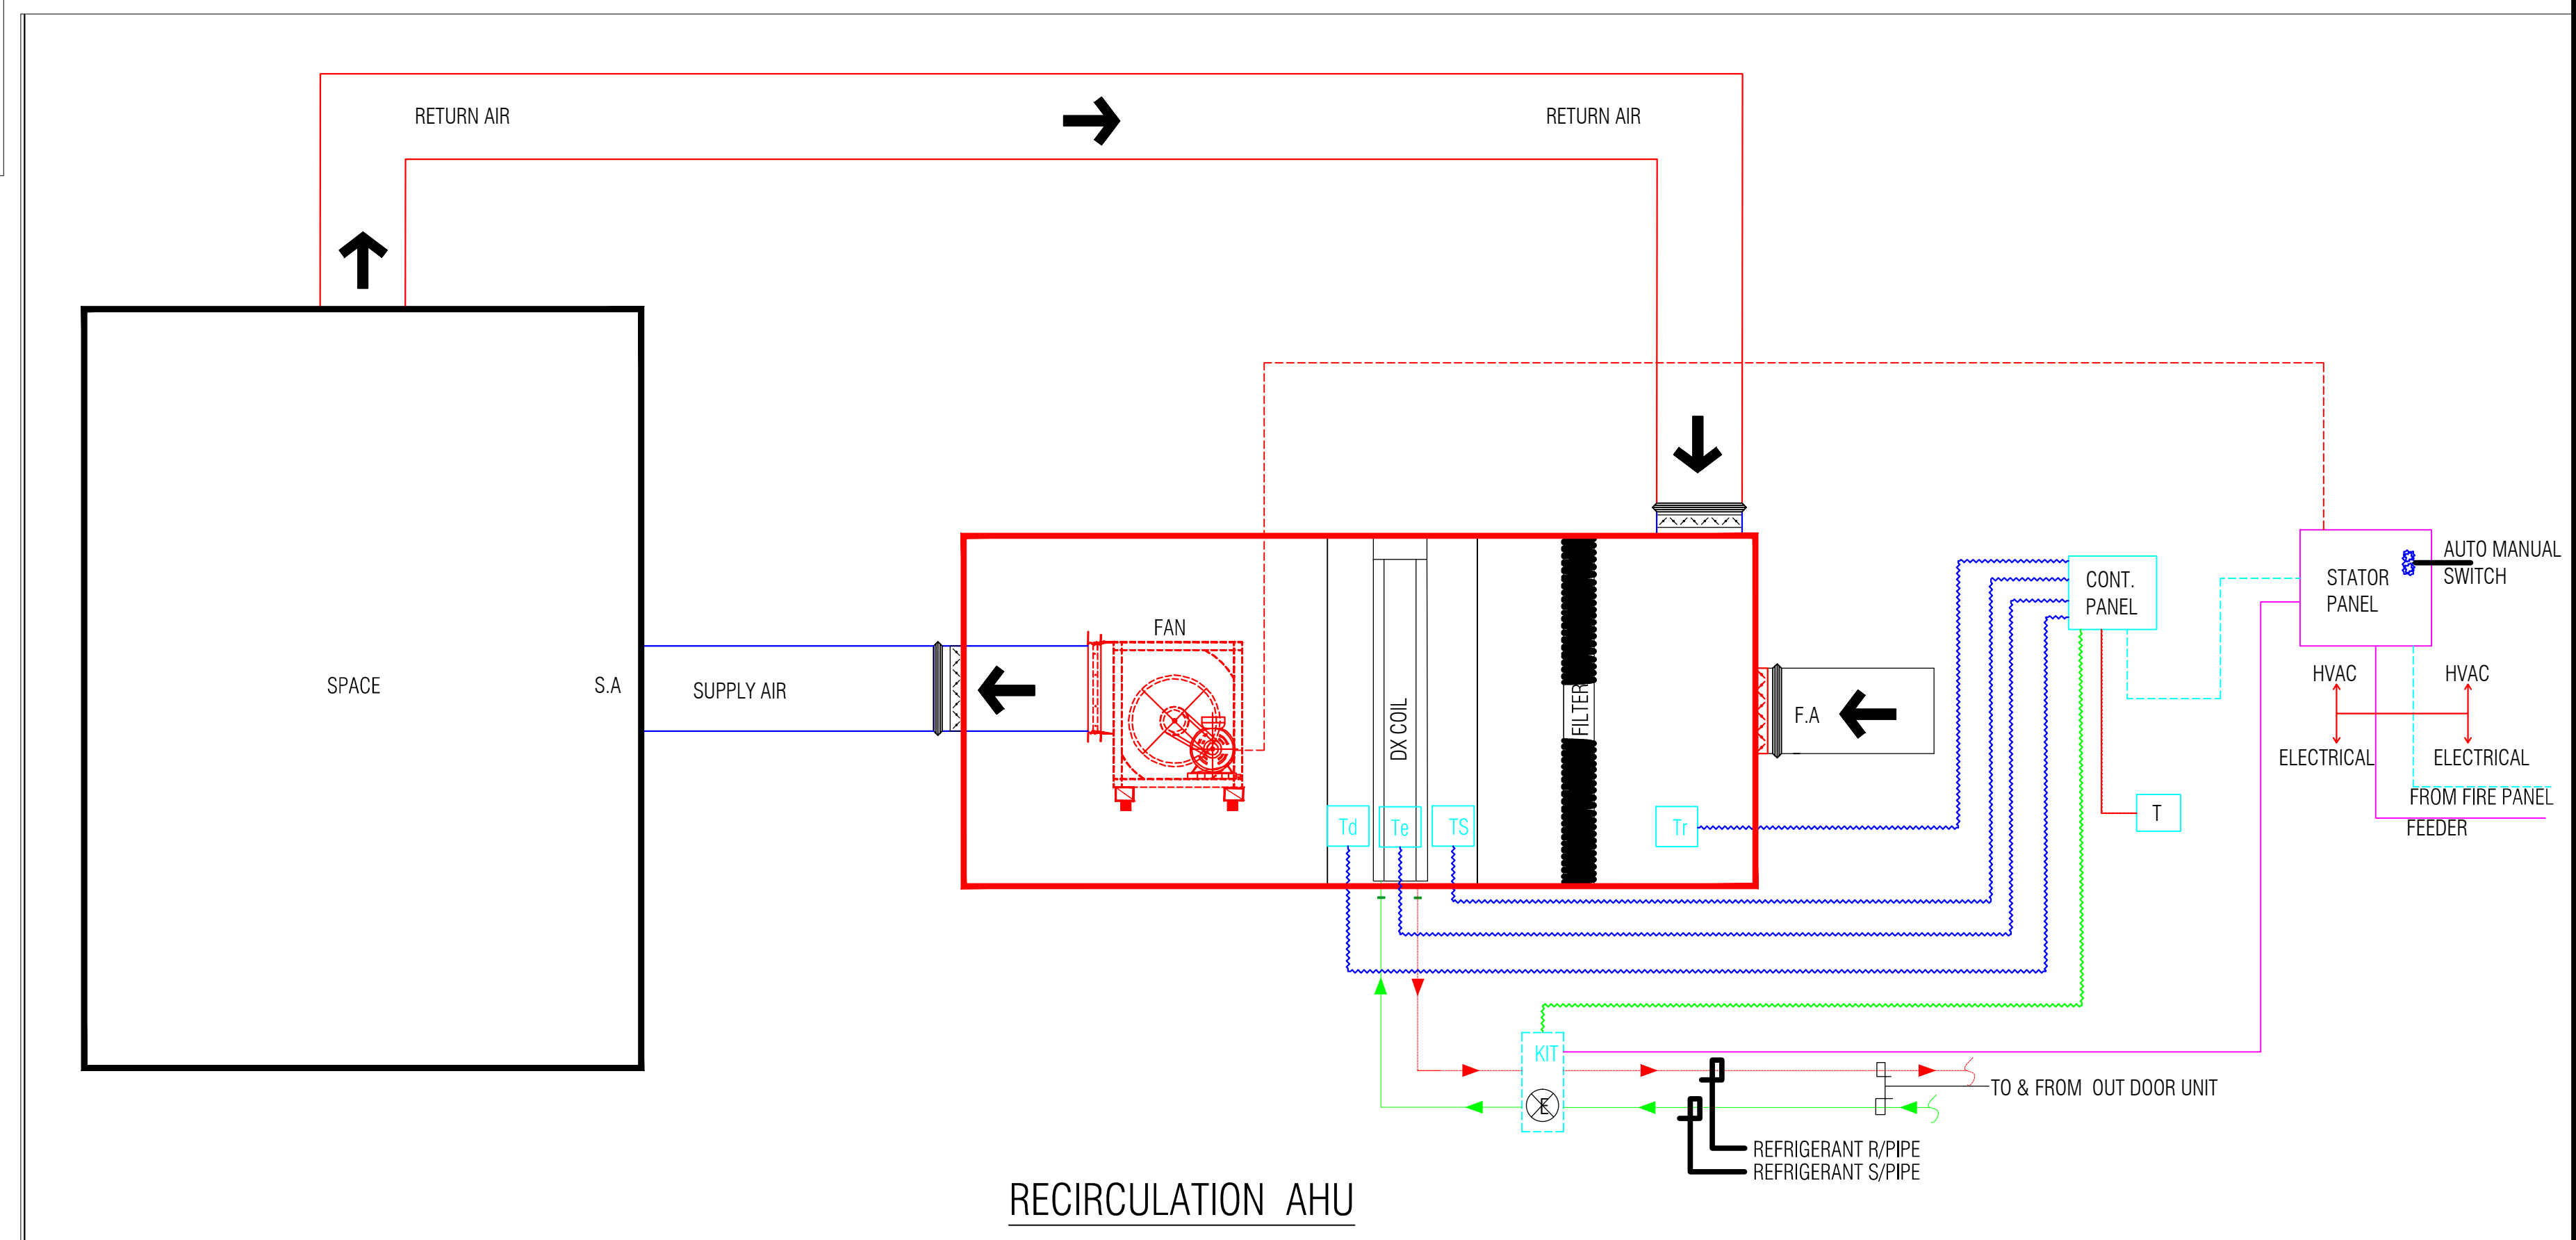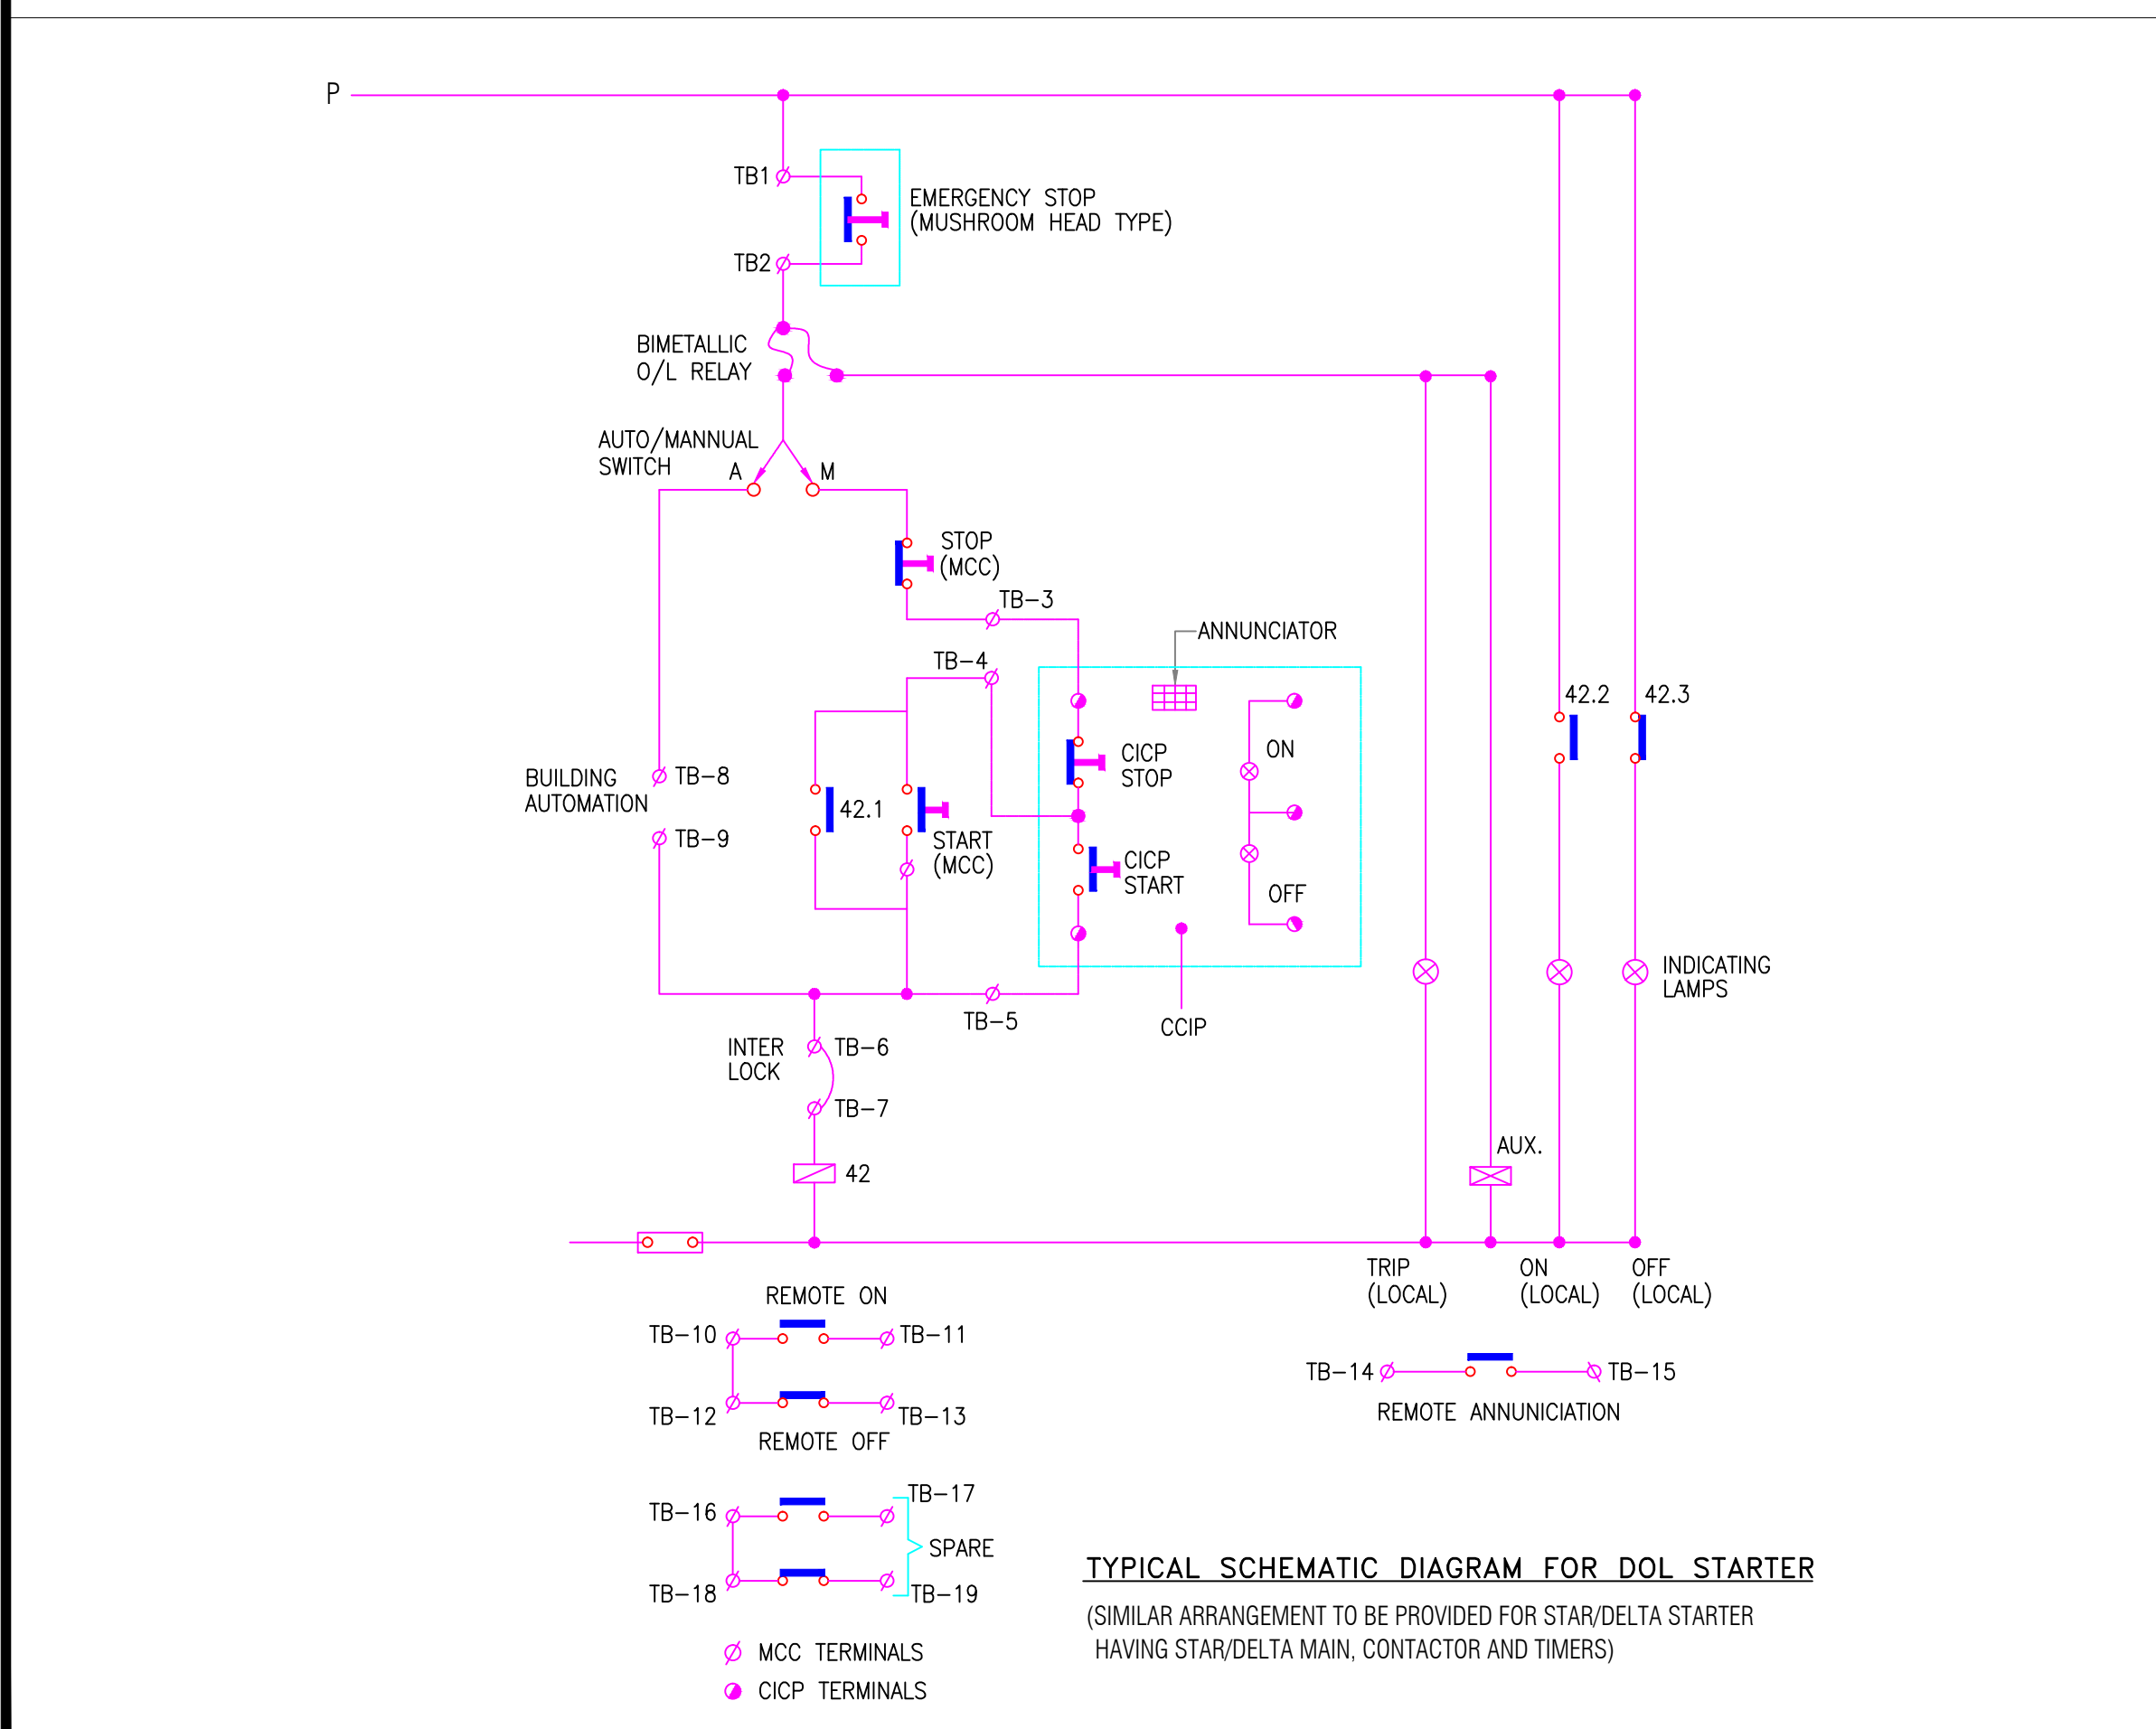

RECIRCULATION AHU

SERVICES CONSULTANT:		PROJECT TITLE		CONSTRUCTION/ EXTENSION OF GURU RAM DAS LANGAR HALL AT SRI HARMANDIR SAHIB, AMRITSAR	
NARINDER SINGH CONSULTING ENGINEERS		DRAWING TITLE		SCHEMATIC AHUs & AIR WASHER CONTROL DIAGRAMS	
G-128, NARAINA VIHAR, NEW DELHI - 110 028 Phones: 011-25793414 E-mail: hvacconsult@hotmail.com,		SCALE	DEALT BY	CHECKED	DATE
		NTS	ASHOK	N.S.	26/7/14
		DRAWING NO.		REVISION NO. / REV. DATE	
		HVAC- 8		10 / 21.5.22	